




SHOPS MEZZANINE PLAN

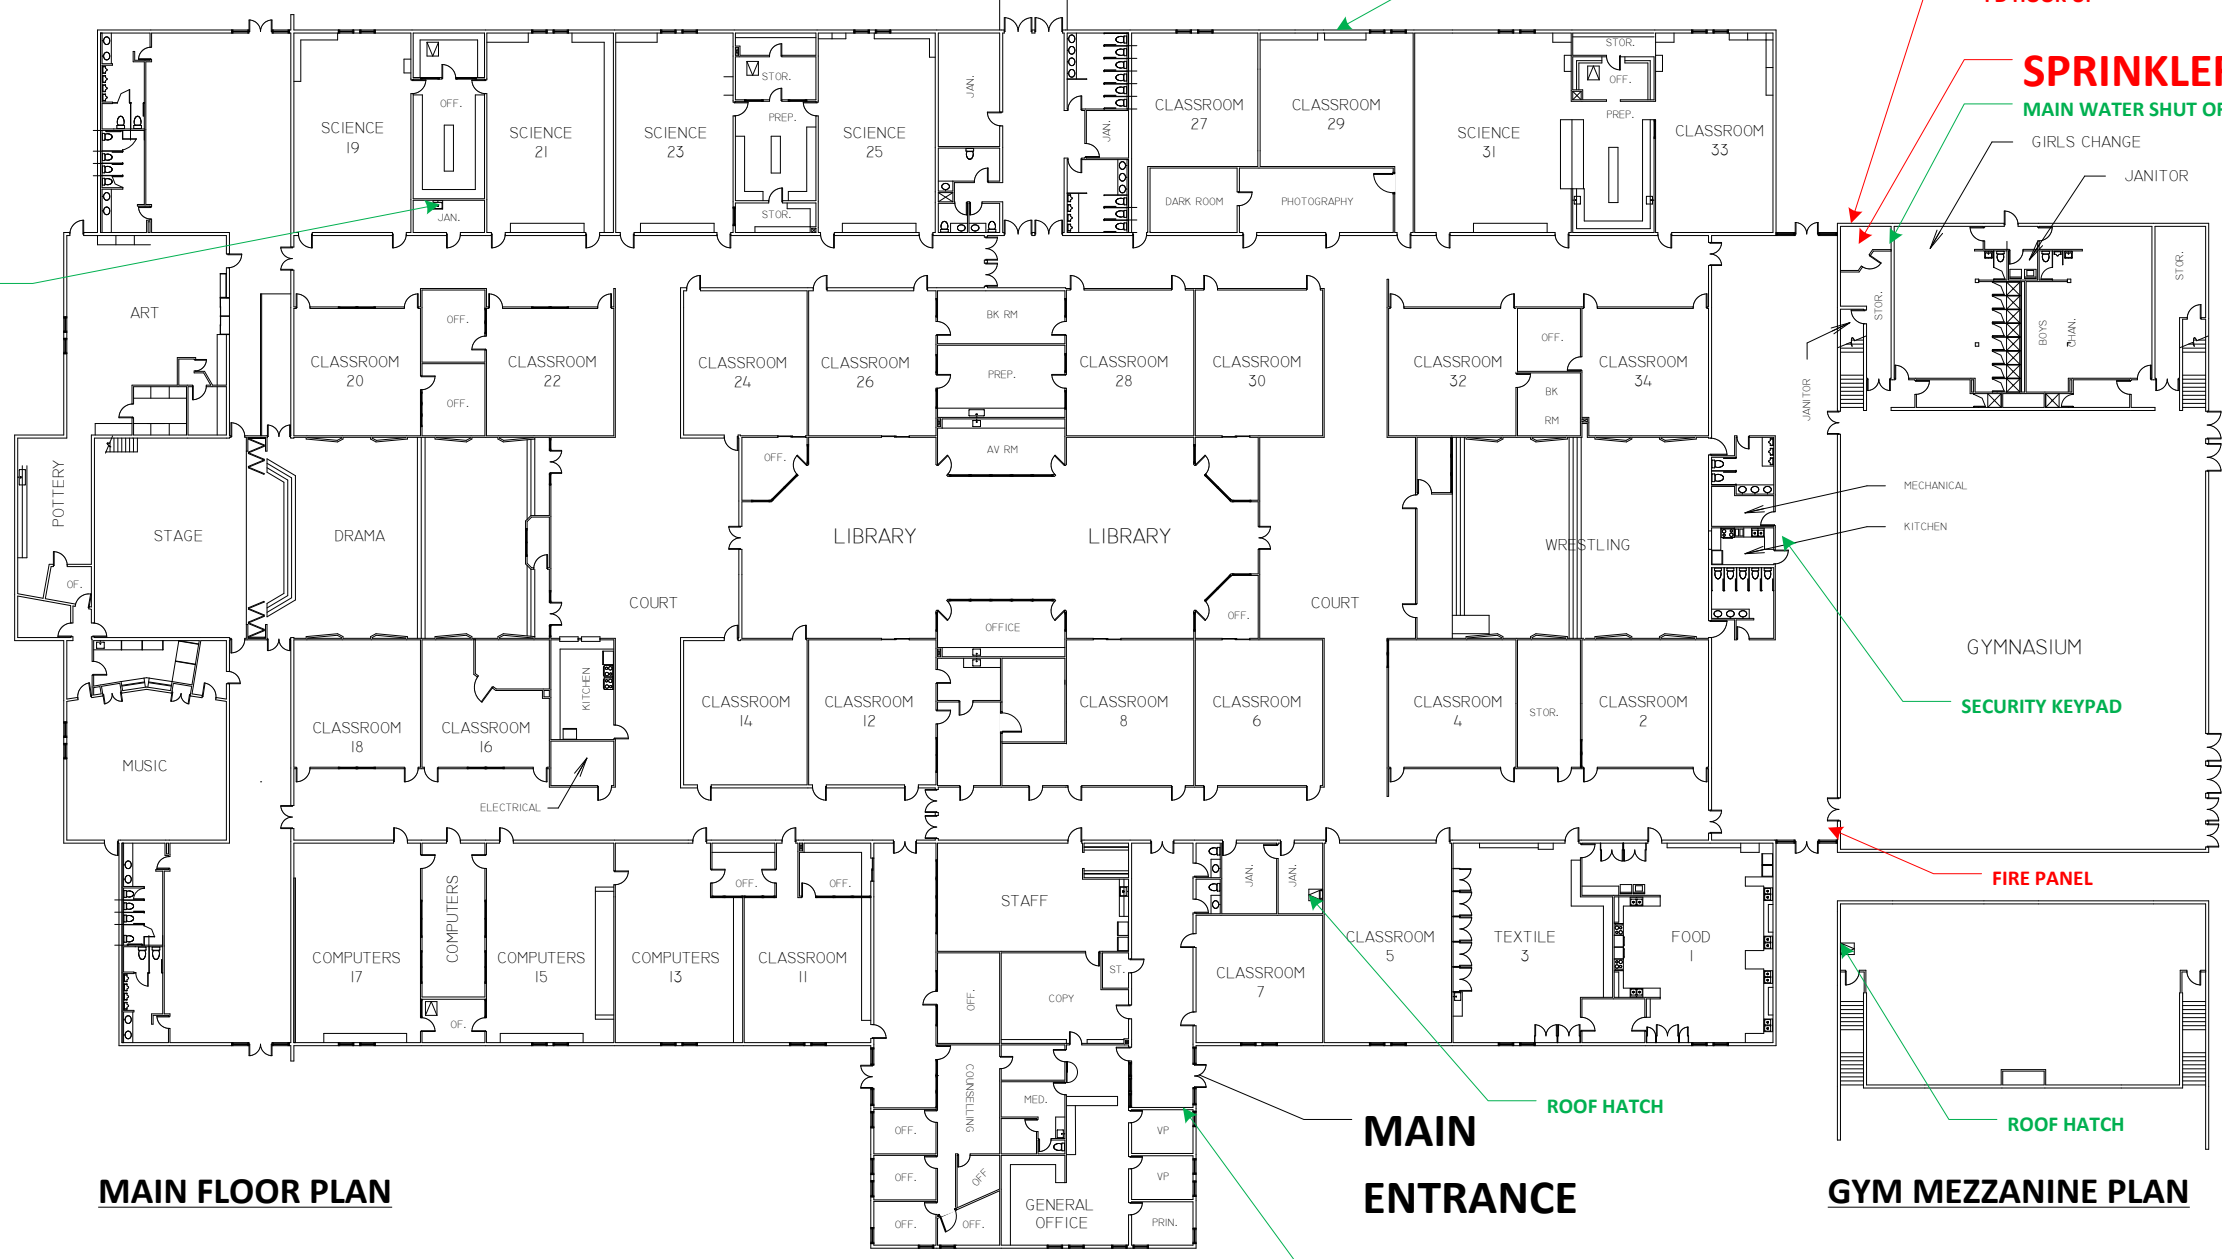

MAIN FLOOR PLAN

MEZZANINE PLAN

GYM MEZZANINE PLAN

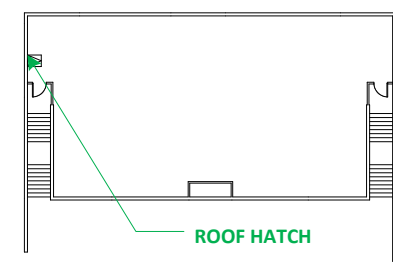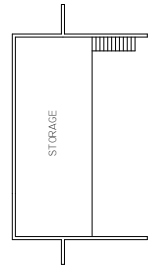

SPRINKLER SYSTEM

SPRINKLER SYSTEM

MAIN ENTRANCE

ROOF HATCH

MAIN GAS VALVE

MAIN CIRCUIT BREAKER

BUILDING GAS VALVE
BUILDING GAS VALVE

FD HOOK UP

MAIN WATER SHUT OFF

GIRLS CHANGE
JANITOR


SECURITY KEYPAD

FIRE PANEL

ROOF HATCH

ROOF HATCH

SECURITY KEYPAD

	
FACILITIES MAINTENANCE AND OPERATIONS 965 NOTRE DAME DRIVE KAMLOOPS, BC V2C 5P8 TEL: 250-851-4420 FAX: 250-851-4421 WWW.SD73.BC.CA	
TITLE	WESTSYDE SECONDARY 855 BEBEK RD KAMLOOPS, BC V2B 6P2 (2500.579.9271)
DESCRIPTION	FLOOR PLANS
DRAWN BY	JMCFADDEN
DATE	24/01/2013
SCALE	1: 300
REVISD	26/02/2014
PAGE	AI